

**DES 21 RESIDENTIAL
HOUSE PROJECT**

404 ERROR LANE
NOWHERE, NONEXISTANT

2	4-22-19	TRANSFERED TO DI/GECO
		ARCH TITLE BLOCK
1	5-3-18	FINISHED DRAWING SET
MARK	DATE	DESCRIPTION

ISSUE	
PROJECT NO:	512.404
CAD DWG FILE:	...\\...\\SIERRA COLLEGE\\DES 21\\MY FILES\\EAST-DES 21- MAIN PORTFOLIO FILE.DWG


DRAWN BY: EASTMAN, DANIEL

CHK'D BY:

COPYRIGHT DI/GECO 2019

SHEET TITLE

MAIN FLOOR PLAN

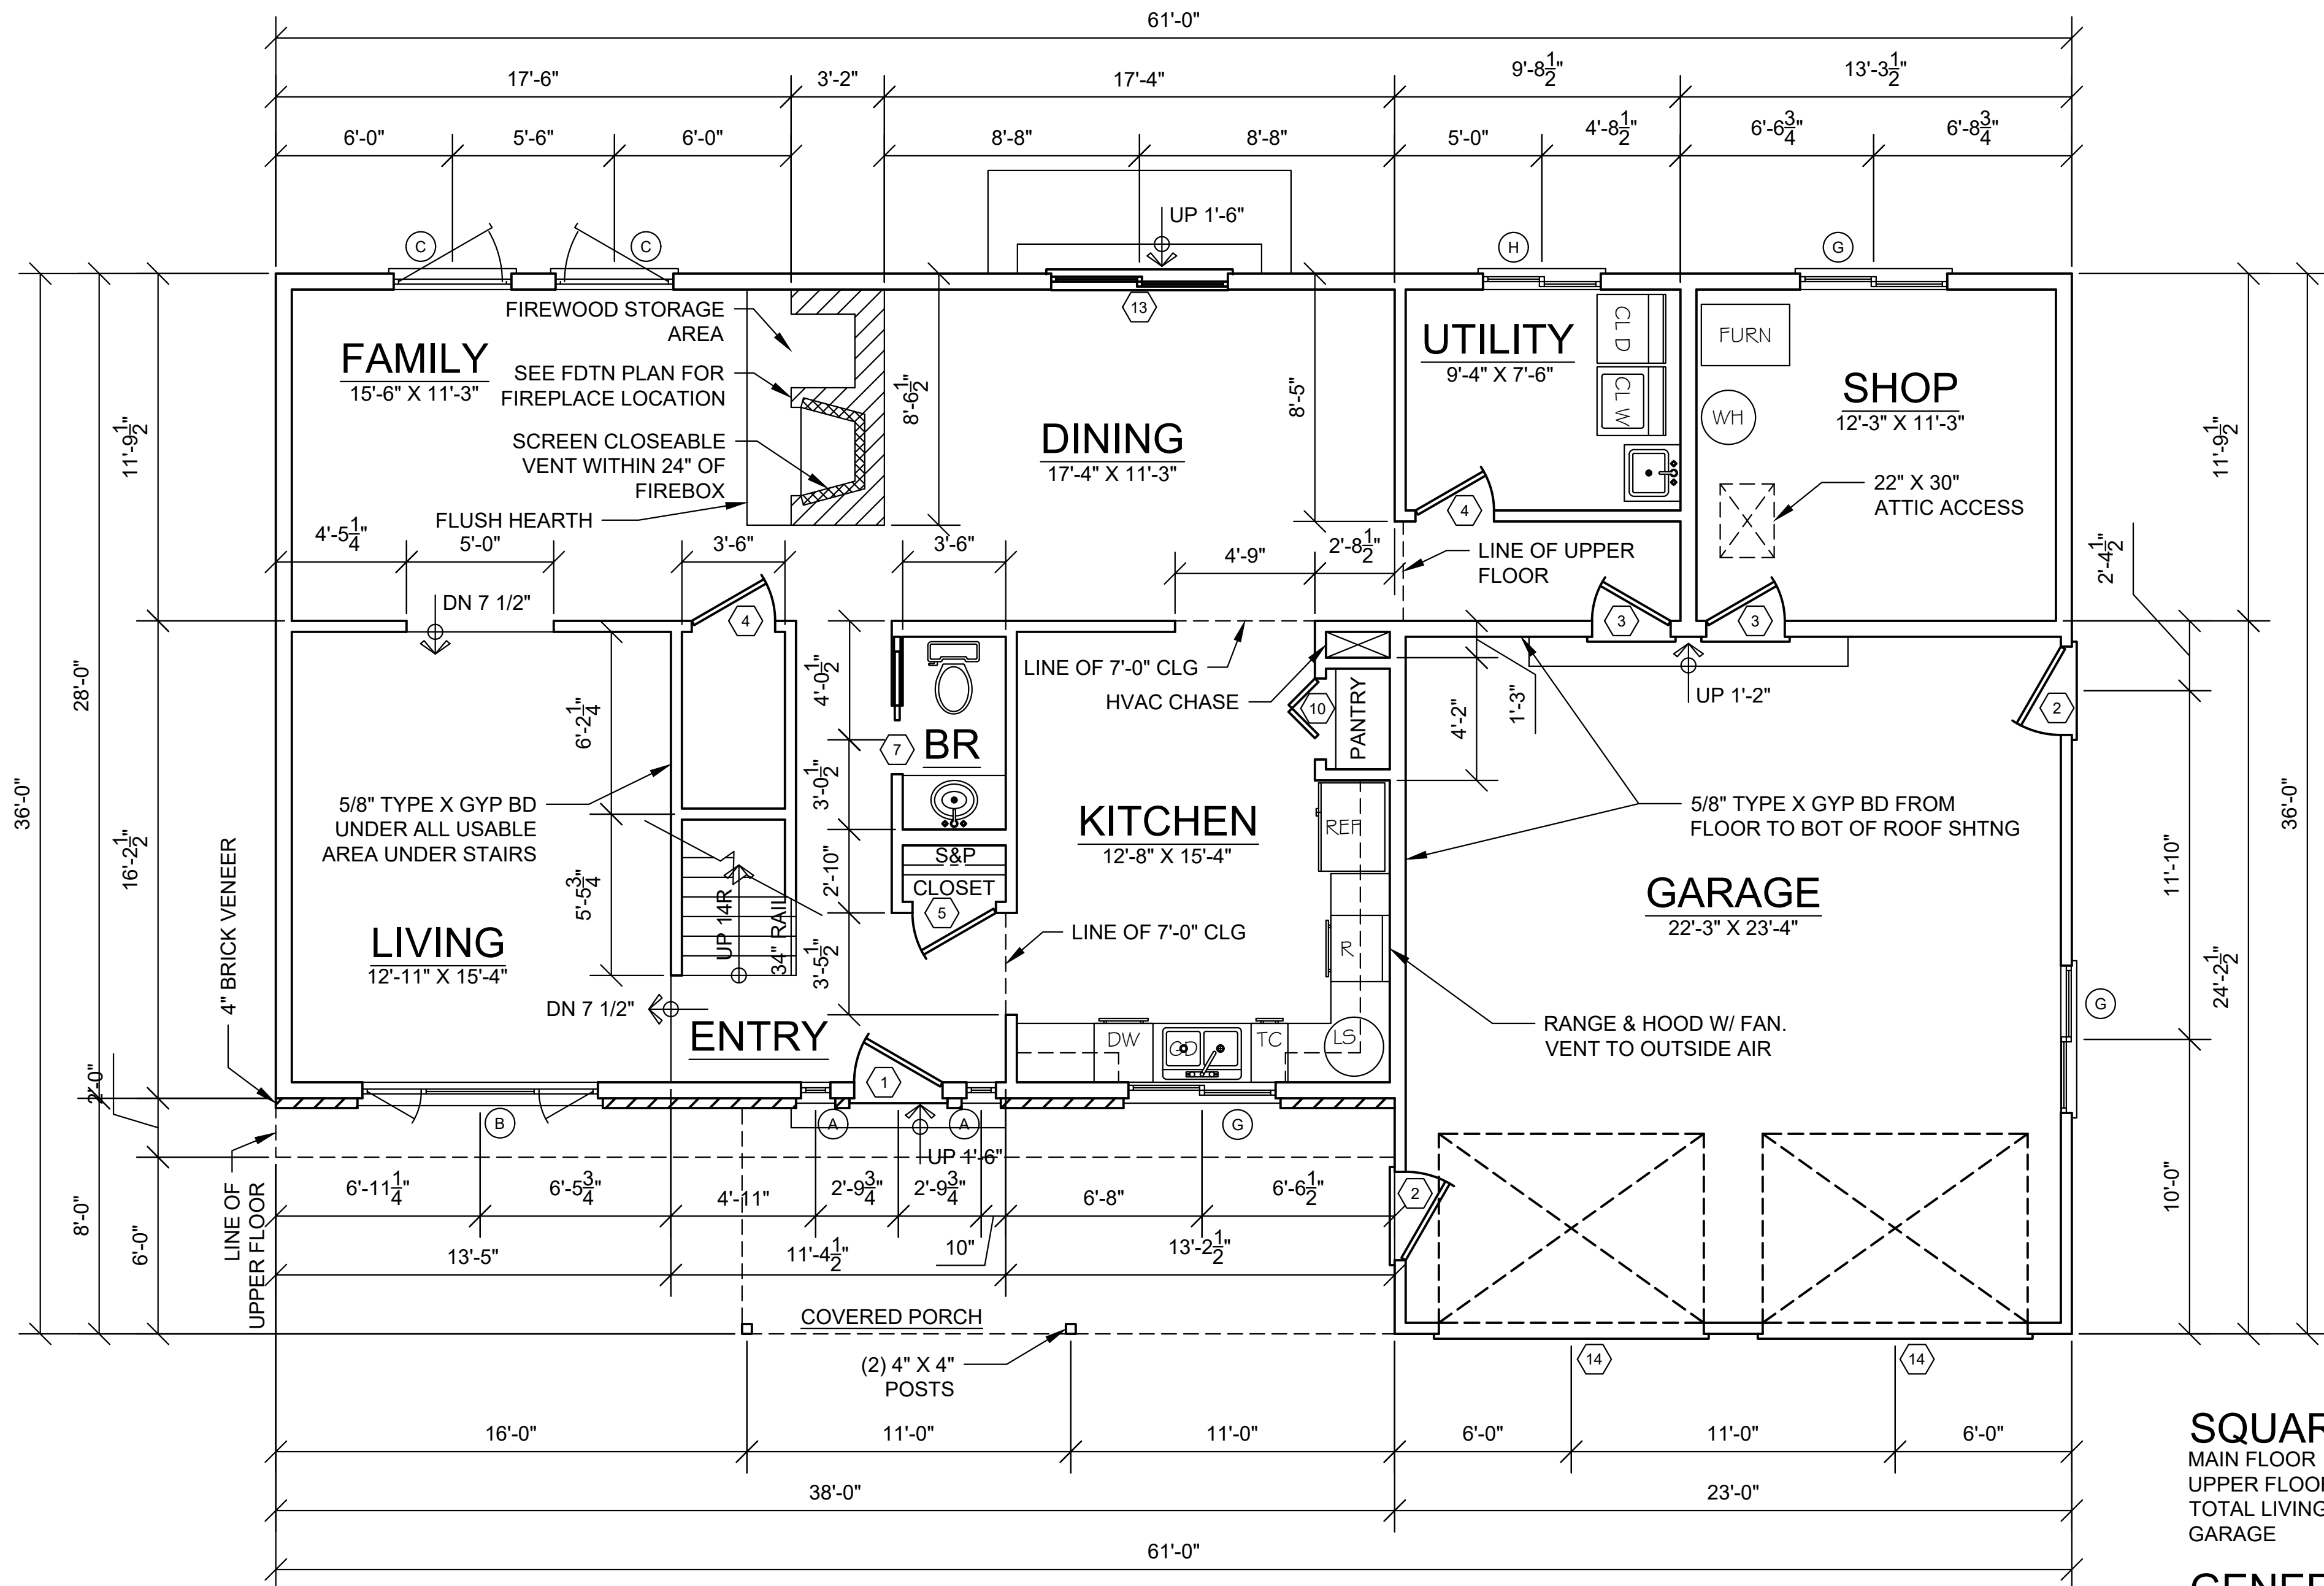

MAIN FLOOR PLAN
SCALE: 1/4" = 1'-0"

SQUARE FOOTAGE

MAIN FLOOR	1103 SQ FT
UPPER FLOOR	947 SQ FT
TOTAL LIVING AREA	2050 SQ FT
GARAGE	518 SQ FT

GENERAL NOTES:

- ALL PENETRATIONS IN TOP OR BOTTOM PLATES FOR PLUMBING OR ELECTRICAL RUNS TO BE SEALED. SEE ELECTRICAL PLANS FOR ADDITIONAL SPECIFICATIONS.
- PROVIDE 1/2" WATERPROOF GYPSUM BOARD AROUND ALL TUBS, SHOWERS, AND SPAS.
- VENT DRYER AND ALL FANS TO OUTSIDE AIR THRU VENT WITH DAMPER.

